


322 323
342 343

323 324
343 344

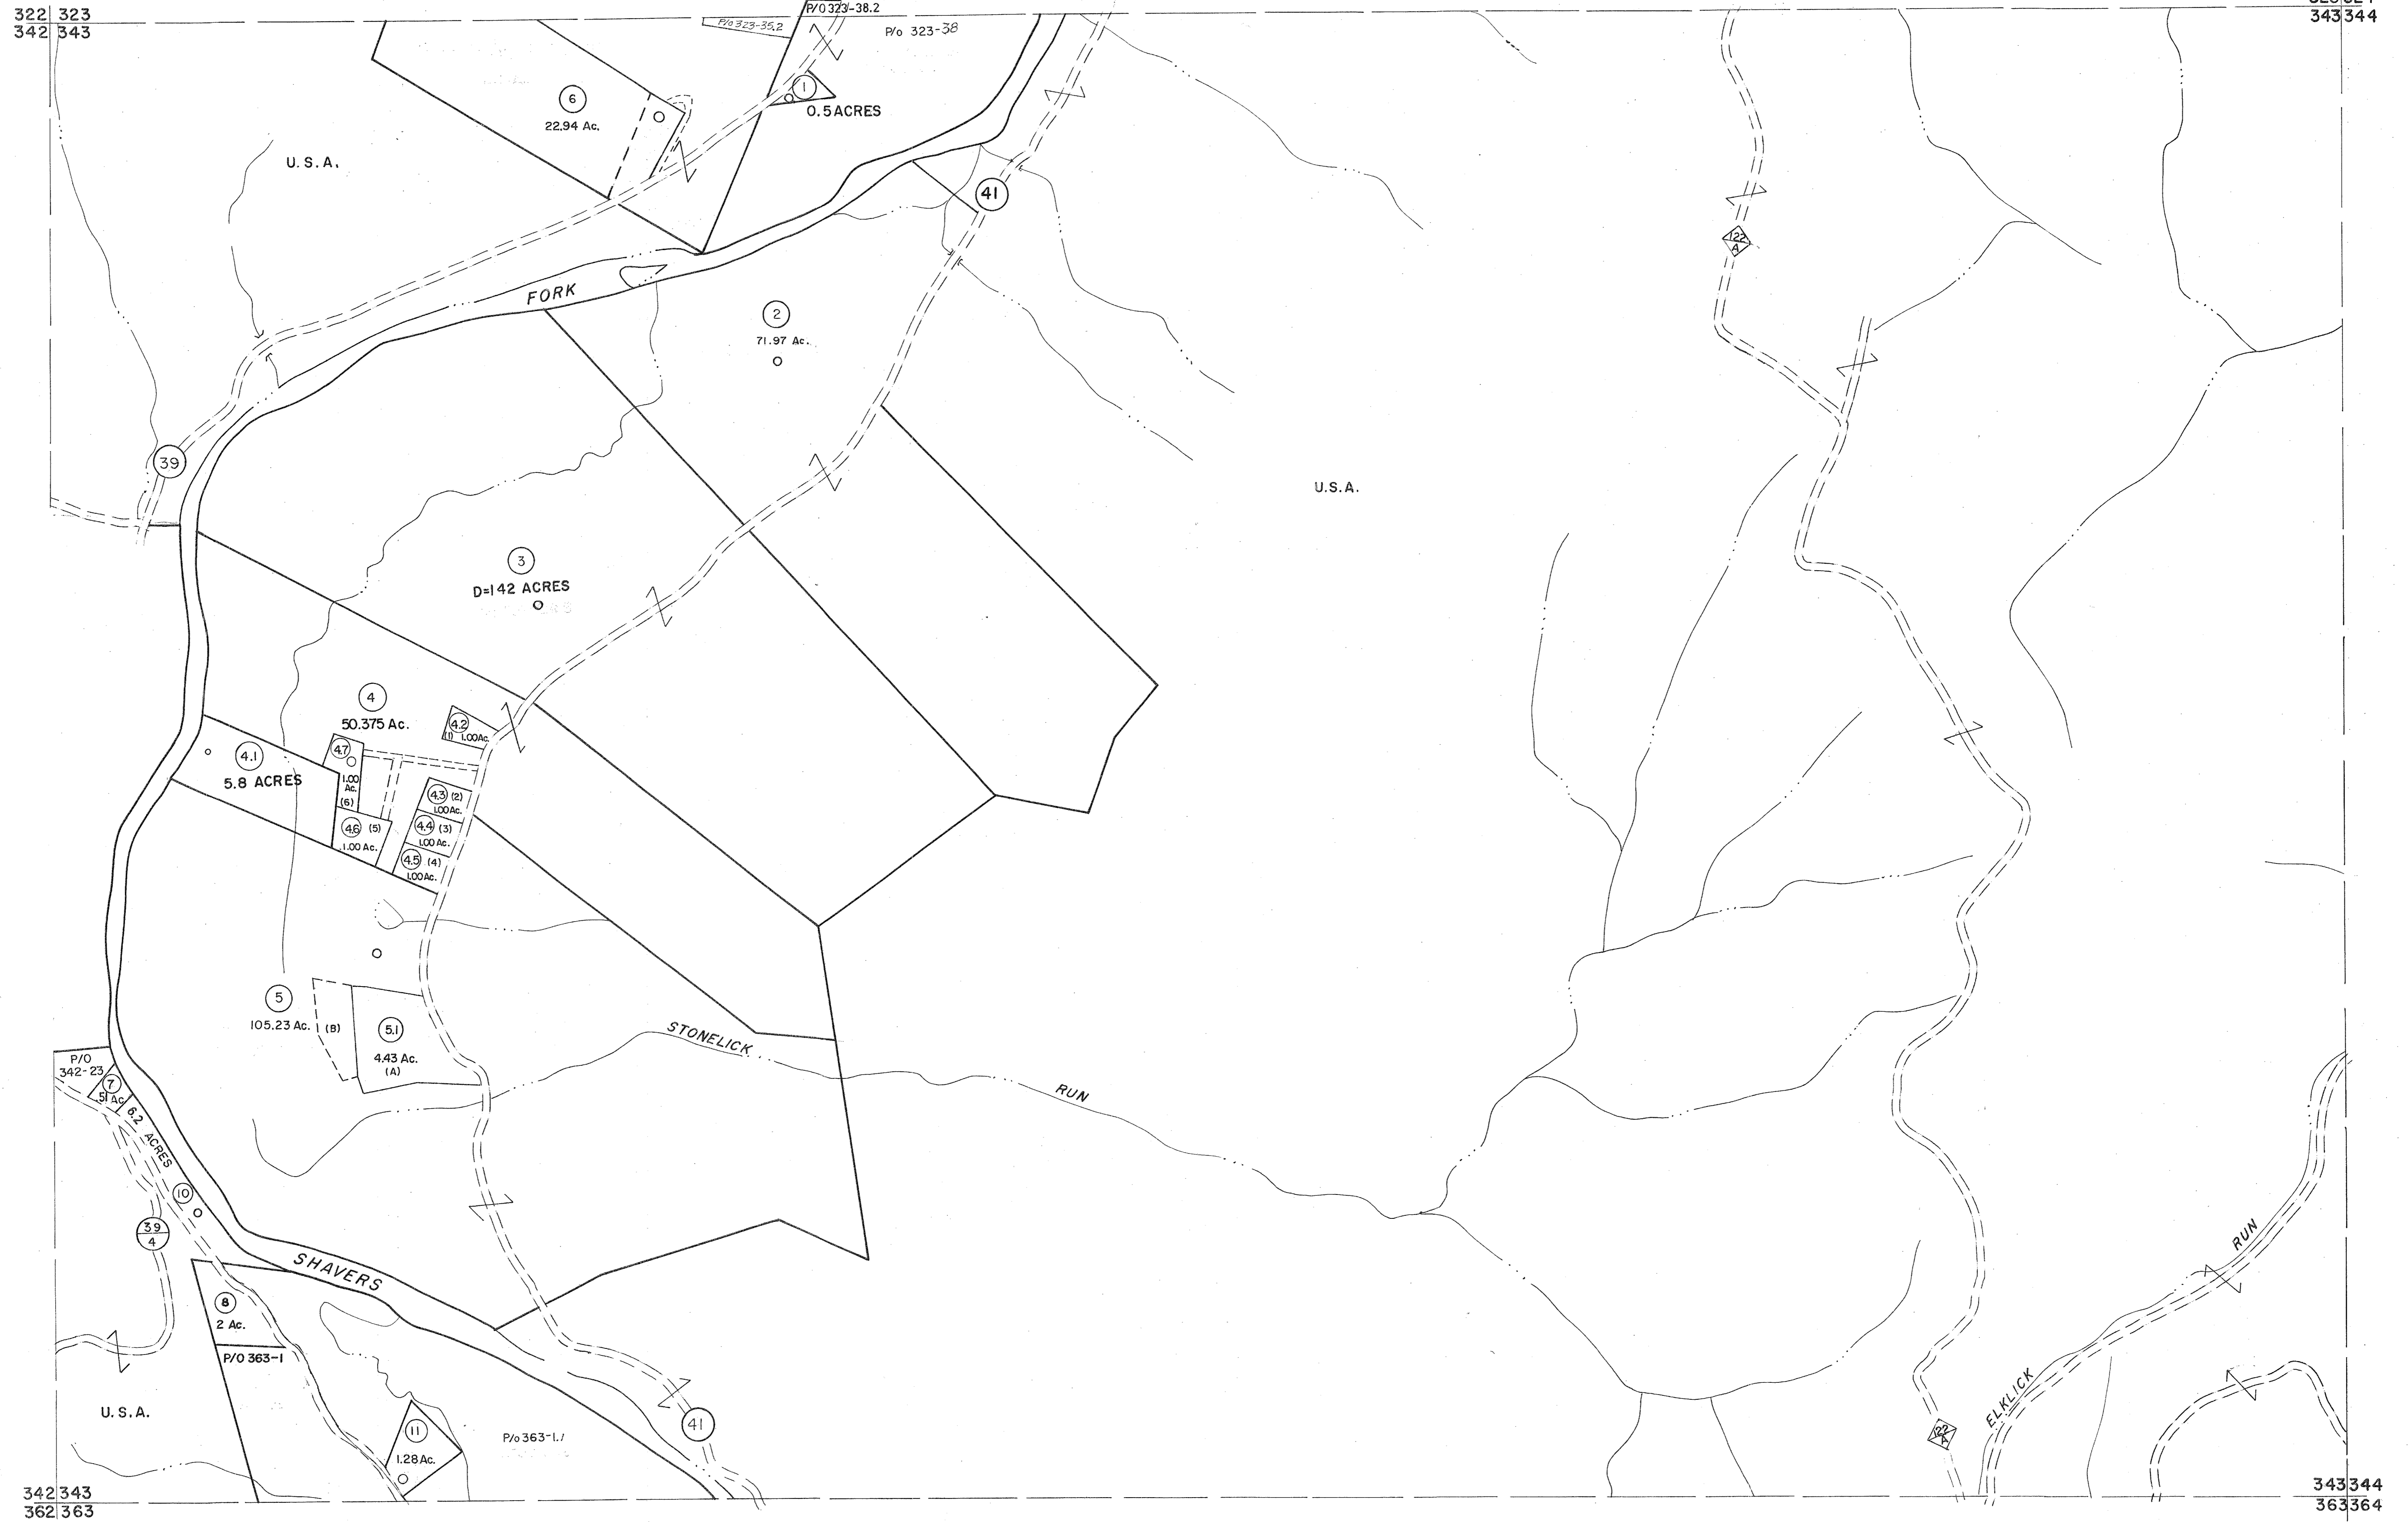

For Tax Purposes Only

Prepared by
MICHAEL BAKER, JR., INC.
Consulting Engineers
Rochester, Pennsylvania


Legend

Property line	—	Original lot line	- - - - -
Edge of pavement or roadway	—	Deed lot number	(15)
Corporation line	—	Parcel or index number	(22)
District line	—	Improvement	o
County line	—	Railroad	+

Revisions

1	11-78	BAH	9	ESI	2/2/02	REK	17
2	Revised to 7-1-85	SP	10	ESI	2/20/03	REK	18
3	July 1985	SP	11		6/24/11	S&H	19
4	Revised to 7-1-87	SP	12		5-4-13	H-45	20
5	OGIS	1/5/91	DSH	13			21
6	OGIS	3-19-92	TL	14			22
7	O.G.I.S.	4-1-96	J.E.B	15			23
8	SLS INC.	DDC 5/97		16			24

KEY MAP

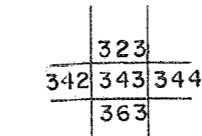

TUCKER COUNTY
STATE OF WEST VIRGINIA
Office of Assessor

DISTRICT

BLACKFORK

SHEET NO: 343

Date, Aerial Photography: November, 1961 Date, Map: Dec., 1962
Photo No: Scale: 1" = 400'