


180
200

180 181
200 201

200
220

200 201
220 221

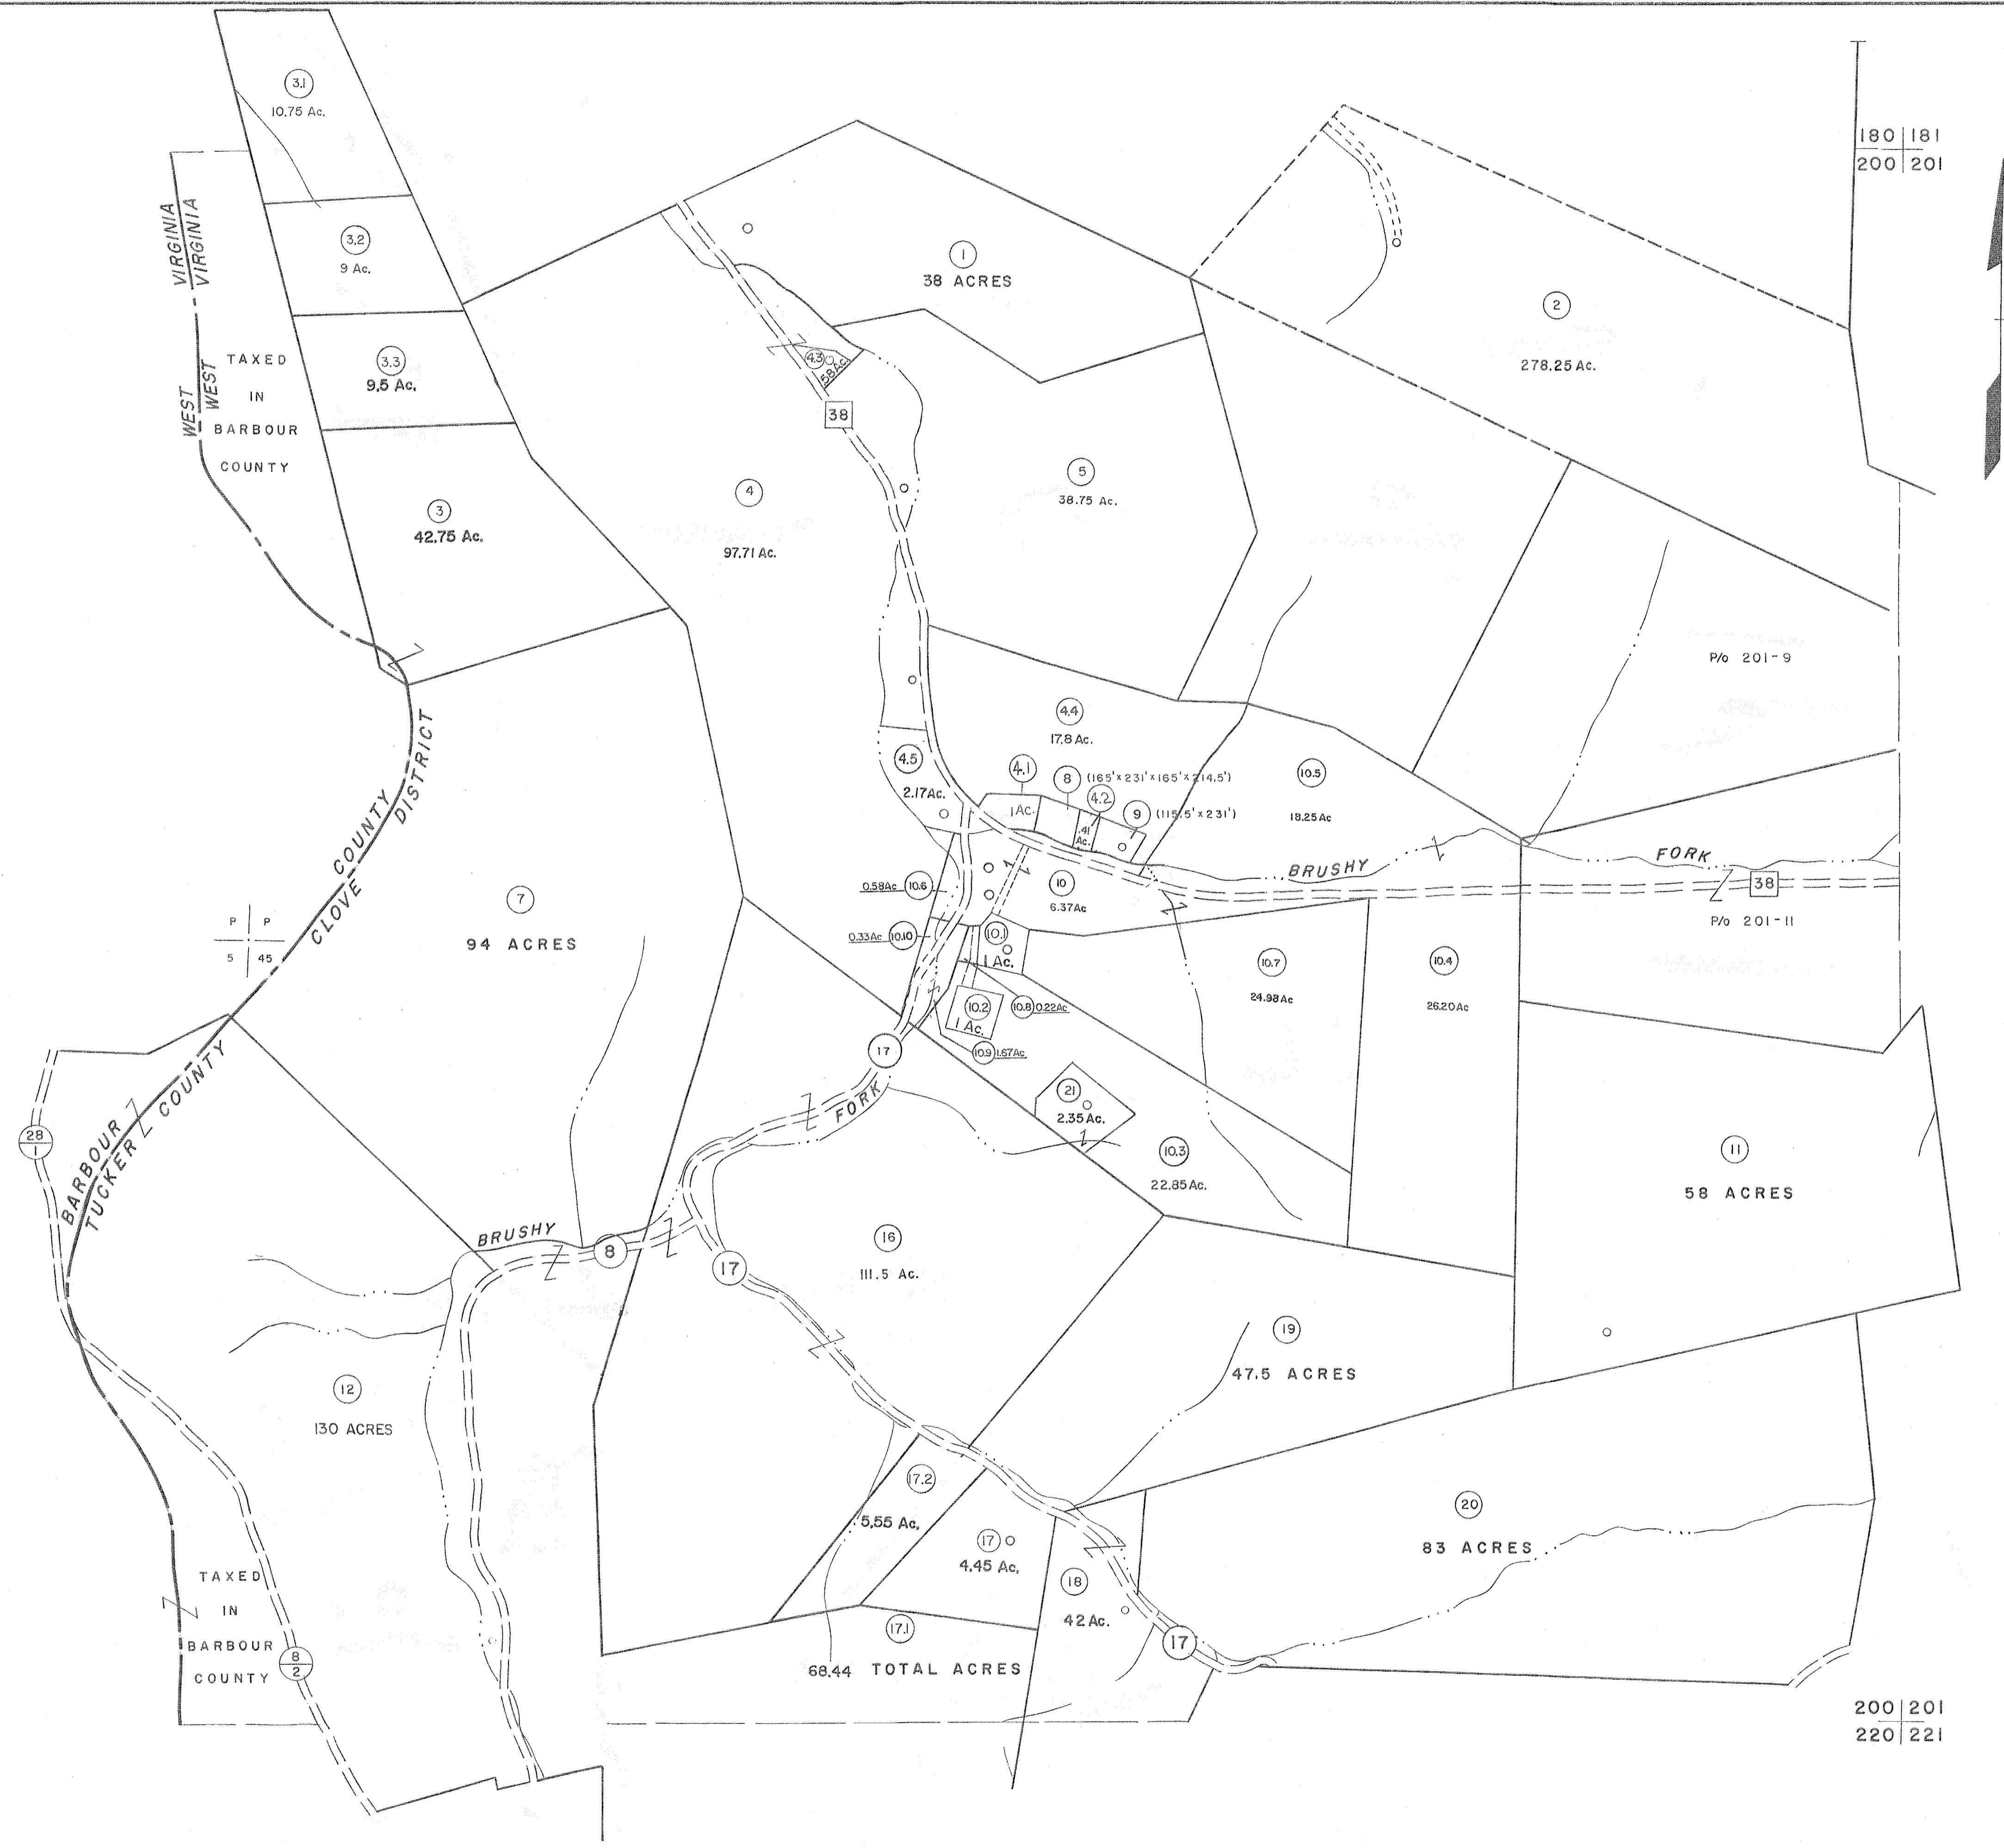

For Tax Purposes Only
 Prepared by
MICHAEL BAKER, JR., INC.
 Consulting Engineers
 Rochester, Pennsylvania

Legend	
Property line	Original lot line
Edge of pavement or roadway	Dead lot number
Corporation line	Parcel or index number
District line	Improvement
County line	Railroad

Revisions					
1	6-3-64	9	SLS INC. - DDC 5/97	17	5-4-13
2	6-3-75	10	SLS INC. 2/19/98 DSW	18	5/26/15
3	Revised 1983	11	SLS INC. 1/27/99 DSW	19	7-19-17
4	Revised to 7-1-85	12	ESI 2/7/02 REK	20	
5	OGIS 12/30/90 DSH	13	HBS 2/22/04	21	
6	OGIS 3-19-92 TL	14	3/21/05 SAH	22	
7	OGIS 2-95 HD	15	6-22-08	23	
8	O.G.I.S 4-1-96 J.E.B	16	5-9-10	24	

KEY MAP

TUCKER COUNTY
 STATE OF WEST VIRGINIA
 Office of Assessor

DISTRICT
CLOVER
 SHEET NO: **200**
 Date, Aerial Photography: Nov., 1961
 Photo No: Date, Map: Dec., 1962
 Scale: 1" = 400'