


P/O 249-3

P/O 249-3



2.15 Ac.
(C)

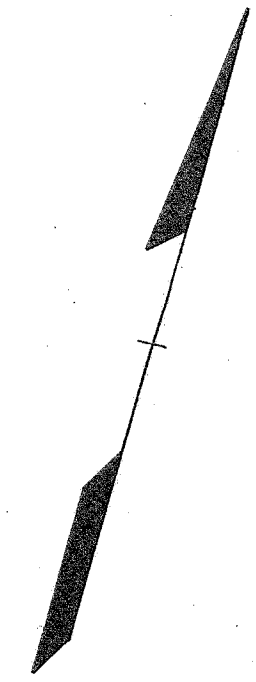

For Tax Purposes Only

Prepared by
MICHAEL BAKER, JR., INC.
Consulting Engineers
Rochester, Pennsylvania


Legend

Property line	---	Original lot line	---
Edge of pavement or roadway	---	Deed lot number	○
Corporation line	---	Parcel or index number	○ (15)
District line	---	Improvement	○
County line	---	Railroad	○

Revisions

1	10-3-63	9	OGIS 1-16-93	DSH	17	6-21-09	TT#5
2	6-6-75	10	OGIS 4-95	HD	18	6/21/11	S&H
3	July 1982	11	SLS INC. - DDC	5/97	19	5-3-13	TT#5
4	Revised to 4-1-85	12	SLS INC. 3/1/00	JWM.	20	5/25/15	S&H
5	REV. TO 7-1-85	13	ESI 1/30/01	REK	21	6-6-2018	Andrew Meador
6	July, 1986	14	ESI 2/5/03	REK	22		
7	OGIS 3-19-92	15	3/28/06	S&H	23		
8		16	4-22-08	TT#5	24		

 KEY MAP



TUCKER COUNTY
STATE OF WEST VIRGINIA
Office of Assessor

DISTRICT

DAVIS (DAVIS)

SHEET NO: 02

Date, Aerial Photography: April, 1961
Photo No: 318 L-17
Date, Map: July, 1962
Scale: 1" = 100'